



FIRST FLOOR
1/16"=1'-0"

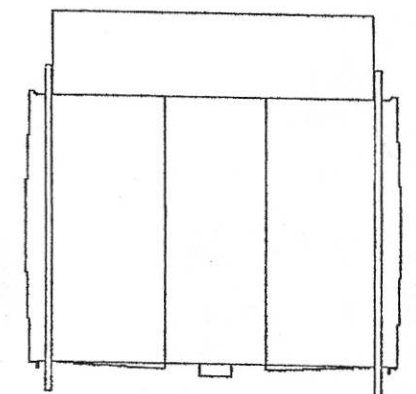


BEDFORD FLIGHT TEST FACILITY
KEY PLAN

REV NO.	DR. PLANT ENG'G.	SCALE: 1/16"=1'-0"	 ELECTRONIC SYSTEMS FACILITIES DEPARTMENT	
	DATE	DATE:		
	CUST.	DATE:		
	SAFE.	DATE:		
REVISIONS	ENGR.	DATE:	FILE NAME	
	ENGR.	DATE:	FTF BEDFTF-1.DWG	
	APPD.	DATE:	CLASSIFICATION	SIZE
	APPD.	DATE:	LOC.	BUILDING
BEDFORD FLIGHT TEST FACILITY FIRST FLOOR PLAN		DRAWING No. FILE EXT.		

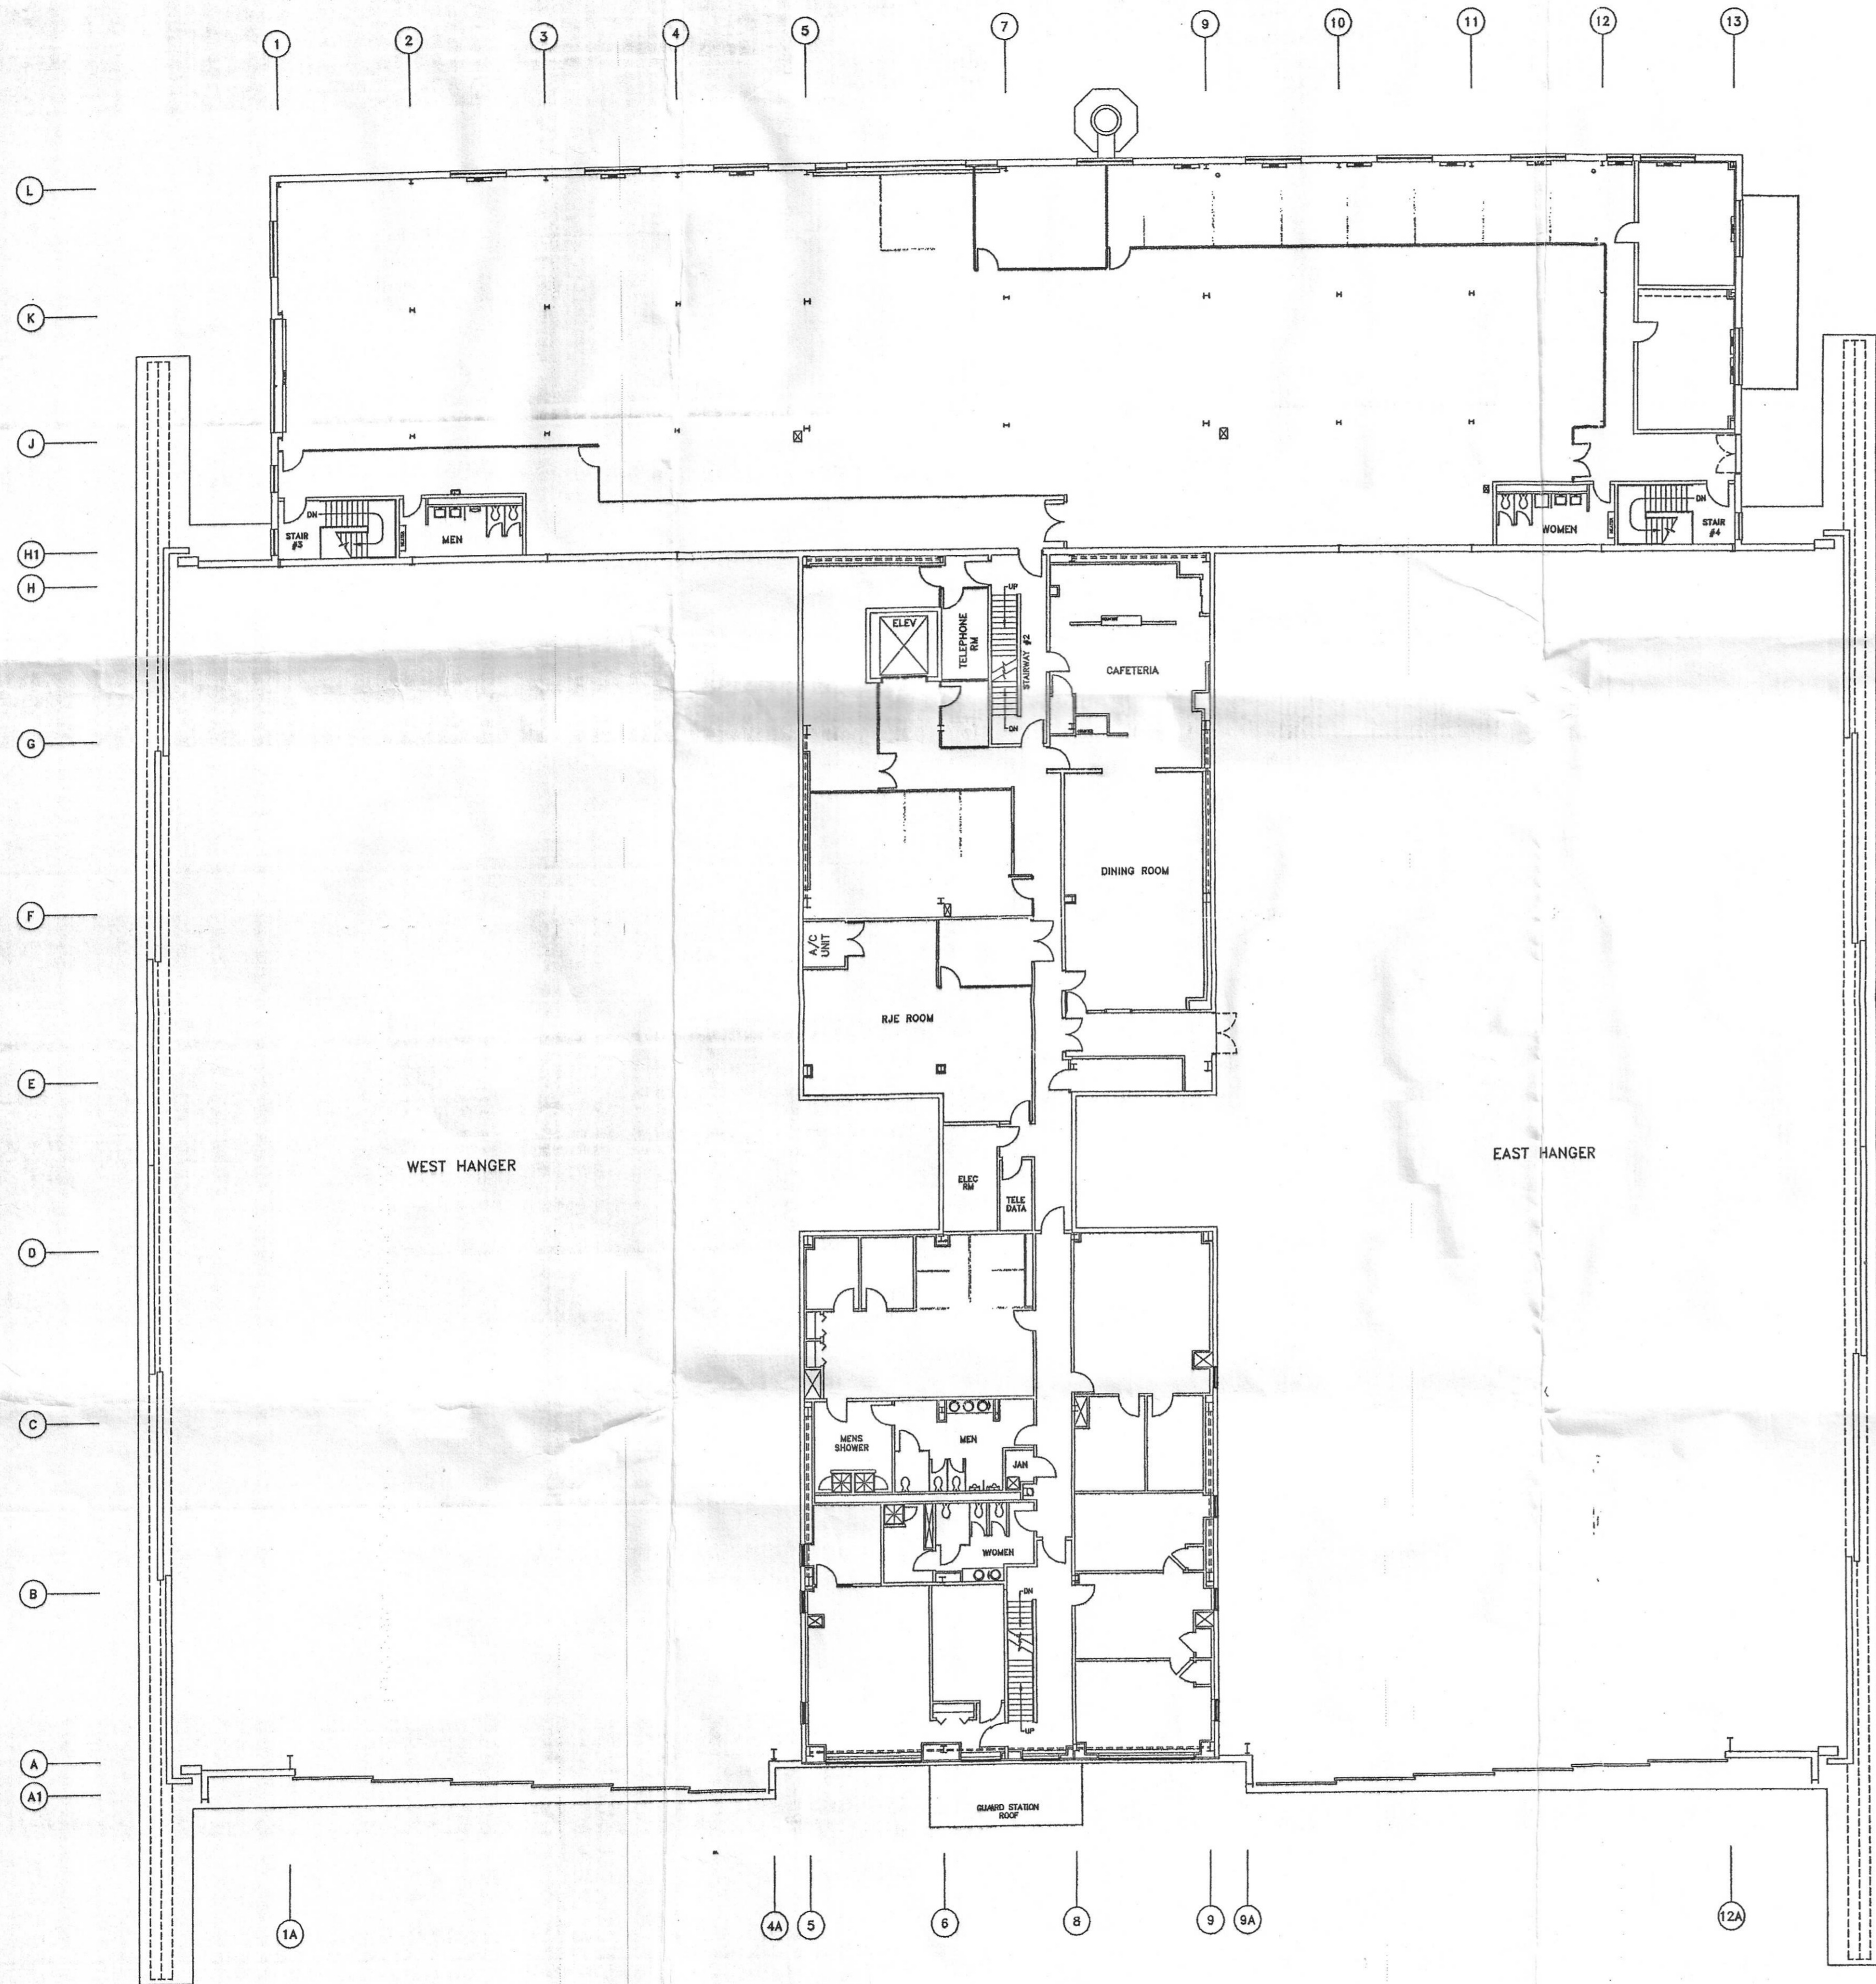



SECOND FLOOR PLAN
1/16"=1'-0"

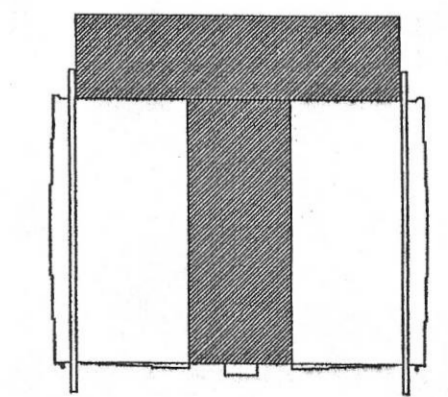


 
BEDFORD FLIGHT TEST FACILITY
KEY PLAN


REVISIONS	DATE	DR. PLANT ENG'G.	SCALE: 1/16"=1'-0"	 ELECTRONIC SYSTEMS FACILITIES DEPARTMENT FSR No:		
	DATE	CUST.	DATE:			
	DATE	SAFE.	DATE:			
	DATE	ENV.	DATE:			
REV	DATE	ENGR	DATE:	FILE NAME FTF BEDFTF-2.DWG		
	DATE	APPD.	DATE:			
CLASSIFICATION		SIZE	LOC.	BUILDING	DRAWING No.	FILE EXT.
UNCLASSIFIED		D	BED	FTF	BEDFTF-2	.DWG
BEDFORD FLIGHT TEST FACILITY SECOND FLOOR PLAN						

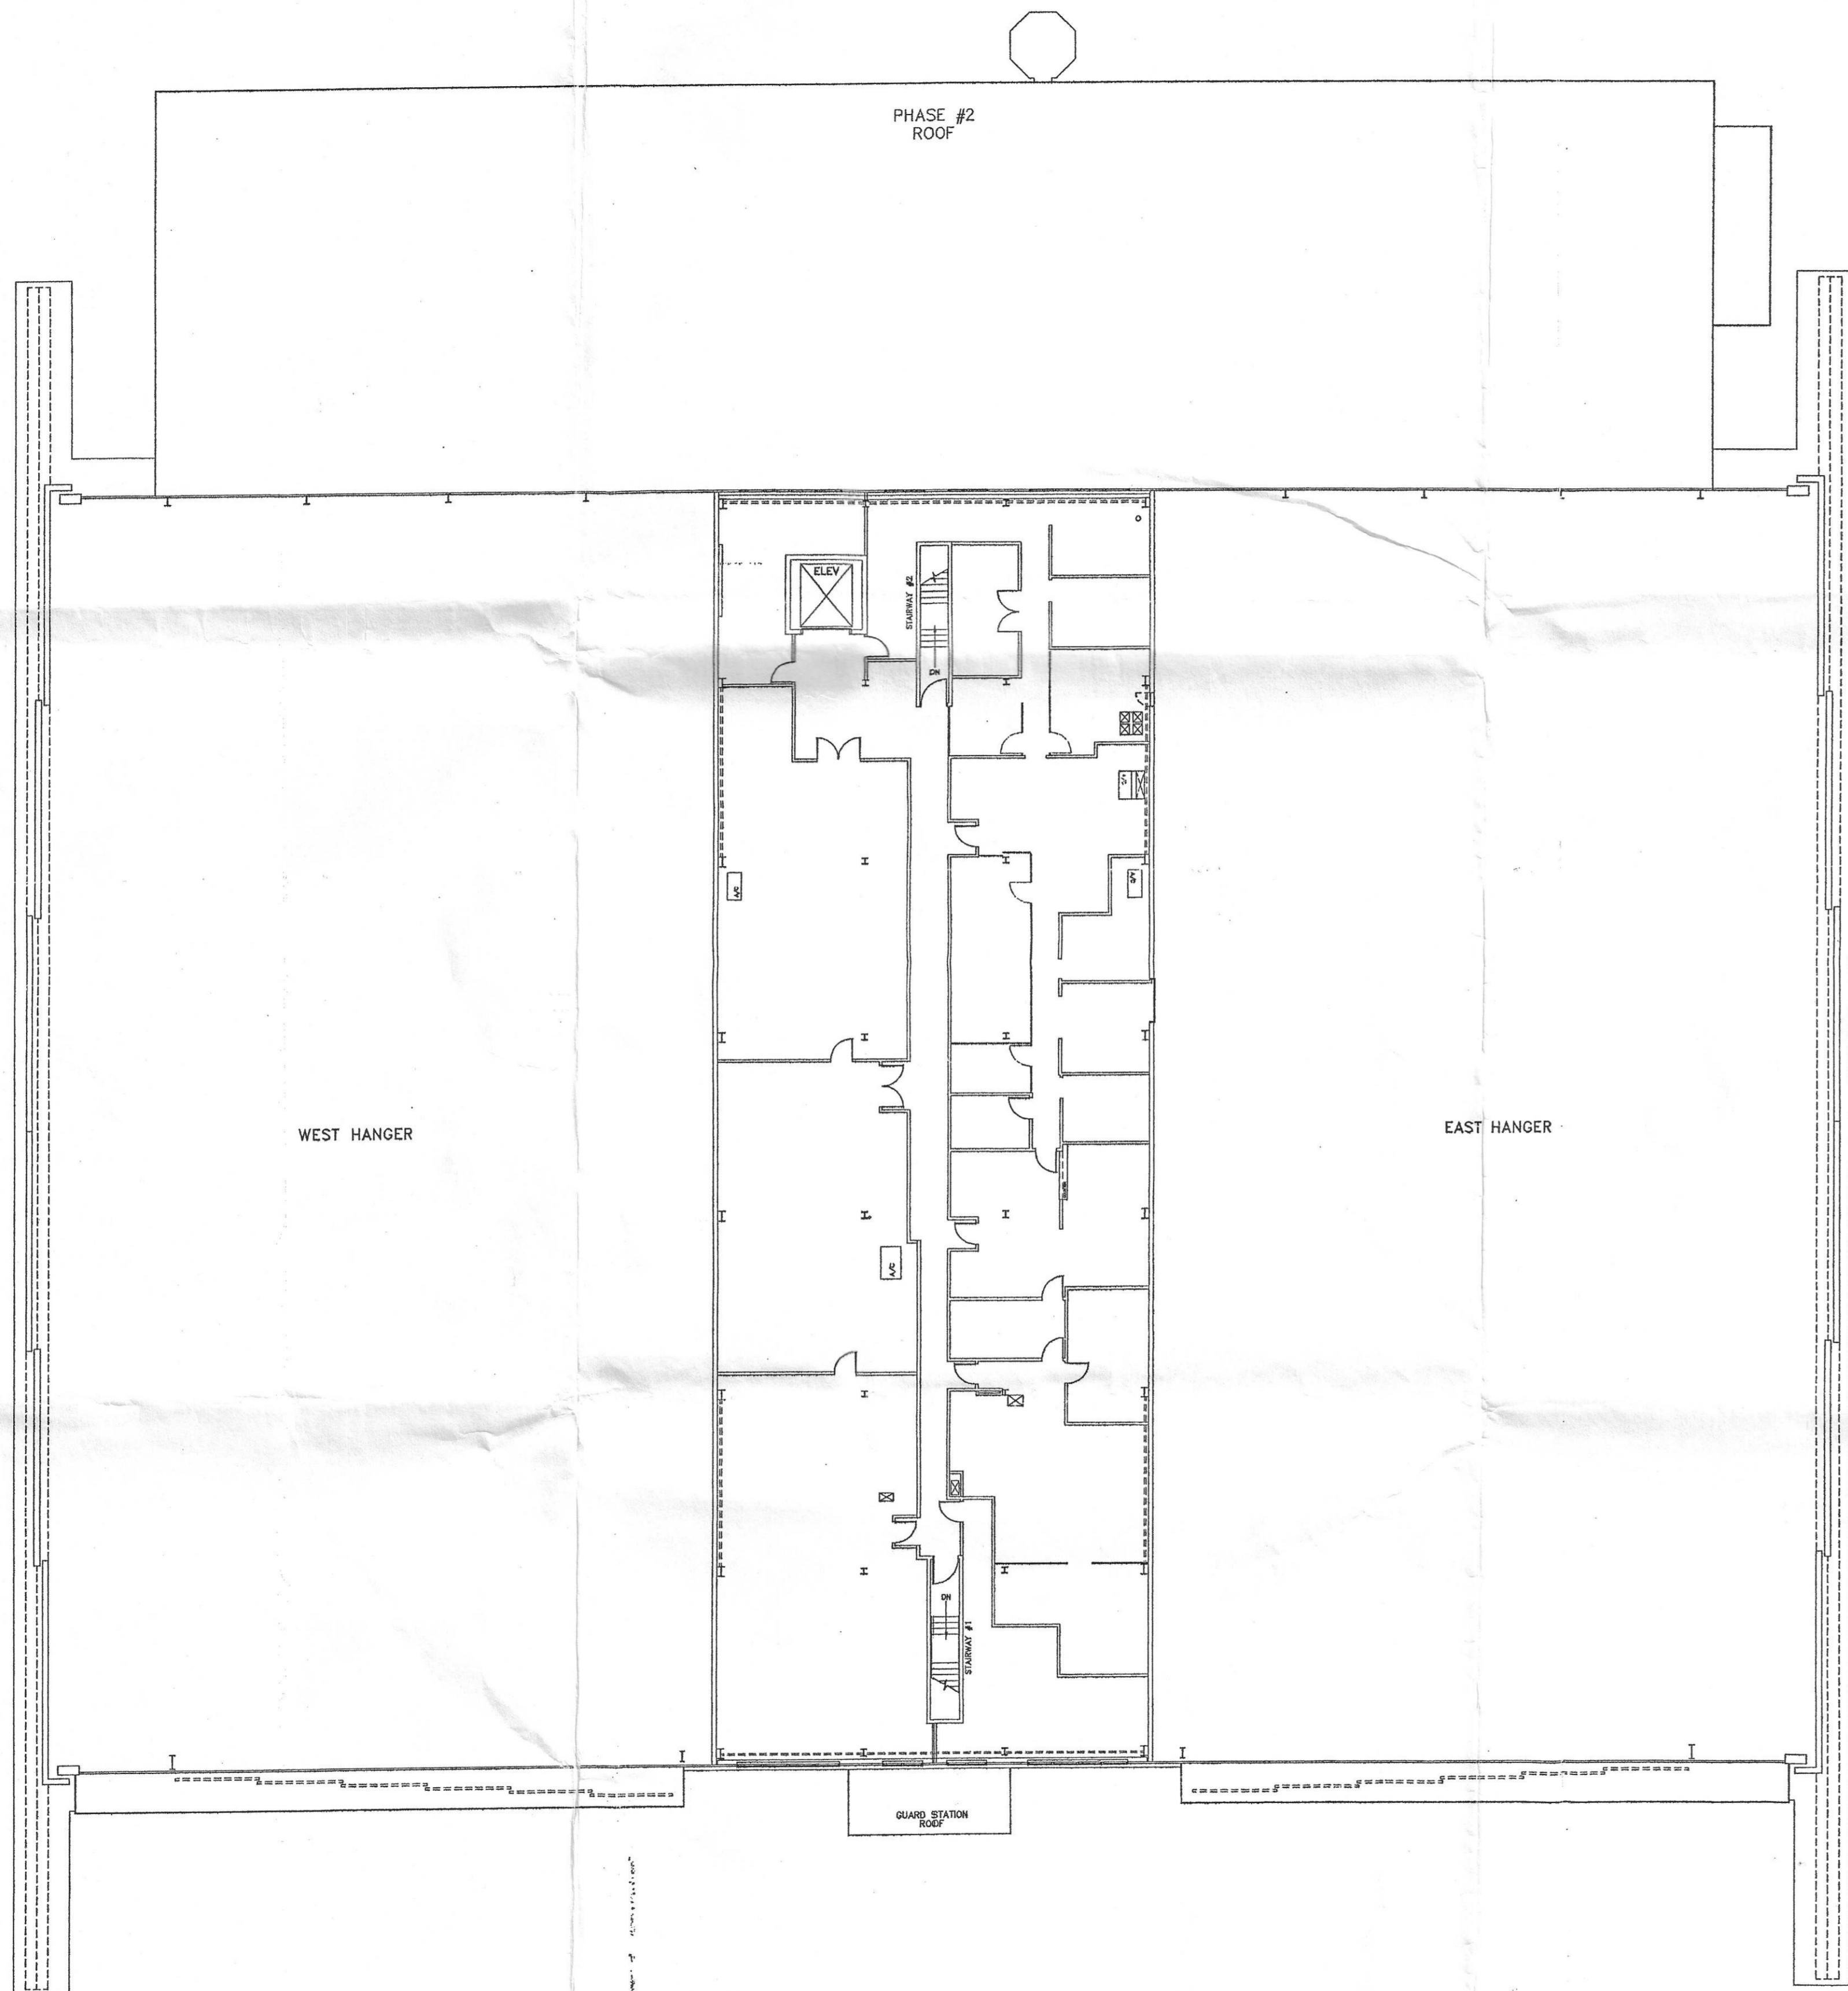

FLIGHT TEST 3rd FLOOR
1/16"=1'-0" 

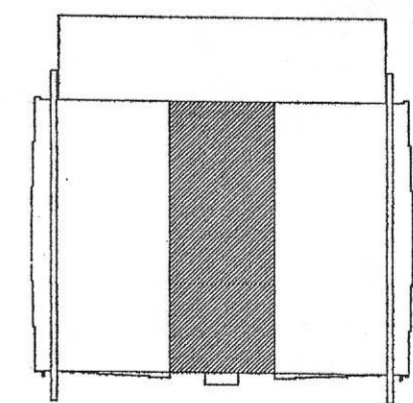

BEDFORD FLIGHT TEST FACILITY
KEY PLAN 

REVISED FLOORPLAN PER FIELD CHANGES: T. HELMER	DATE	DR. PLANT ENG'G.	SCALE: 1/16"=1'-0"	 Raytheon ELECTRONIC SYSTEMS FACILITIES DEPARTMENT	
		CUST.	DATE:		
		SAFE.	DATE:		
		ENV.	DATE:		
		ENGR.	DATE:		
		APPD.	DATE:		
	REVISIONS				FSR No:
	NO.				FILE NAME
	REV				FTF BEDFTF-3.DWG
					CLASSIFICATION SIZE LOC. BUILDING DRAWING No. FILE EXT.
BEDFORD FLIGHT TEST FACILITY THIRD FLOOR PLAN					